


OTHER PLOT COMMUNITY CENTER

BASEMENT LINE

2100 MM HIGH
BOUNDARY WALL
FROM DRAIN TOP2500 SOIL & WASTE PIPE
SLOPE = 1 : 300
INLET PIPE LVL. = -1300 MM

GREEN

PLOT LINE

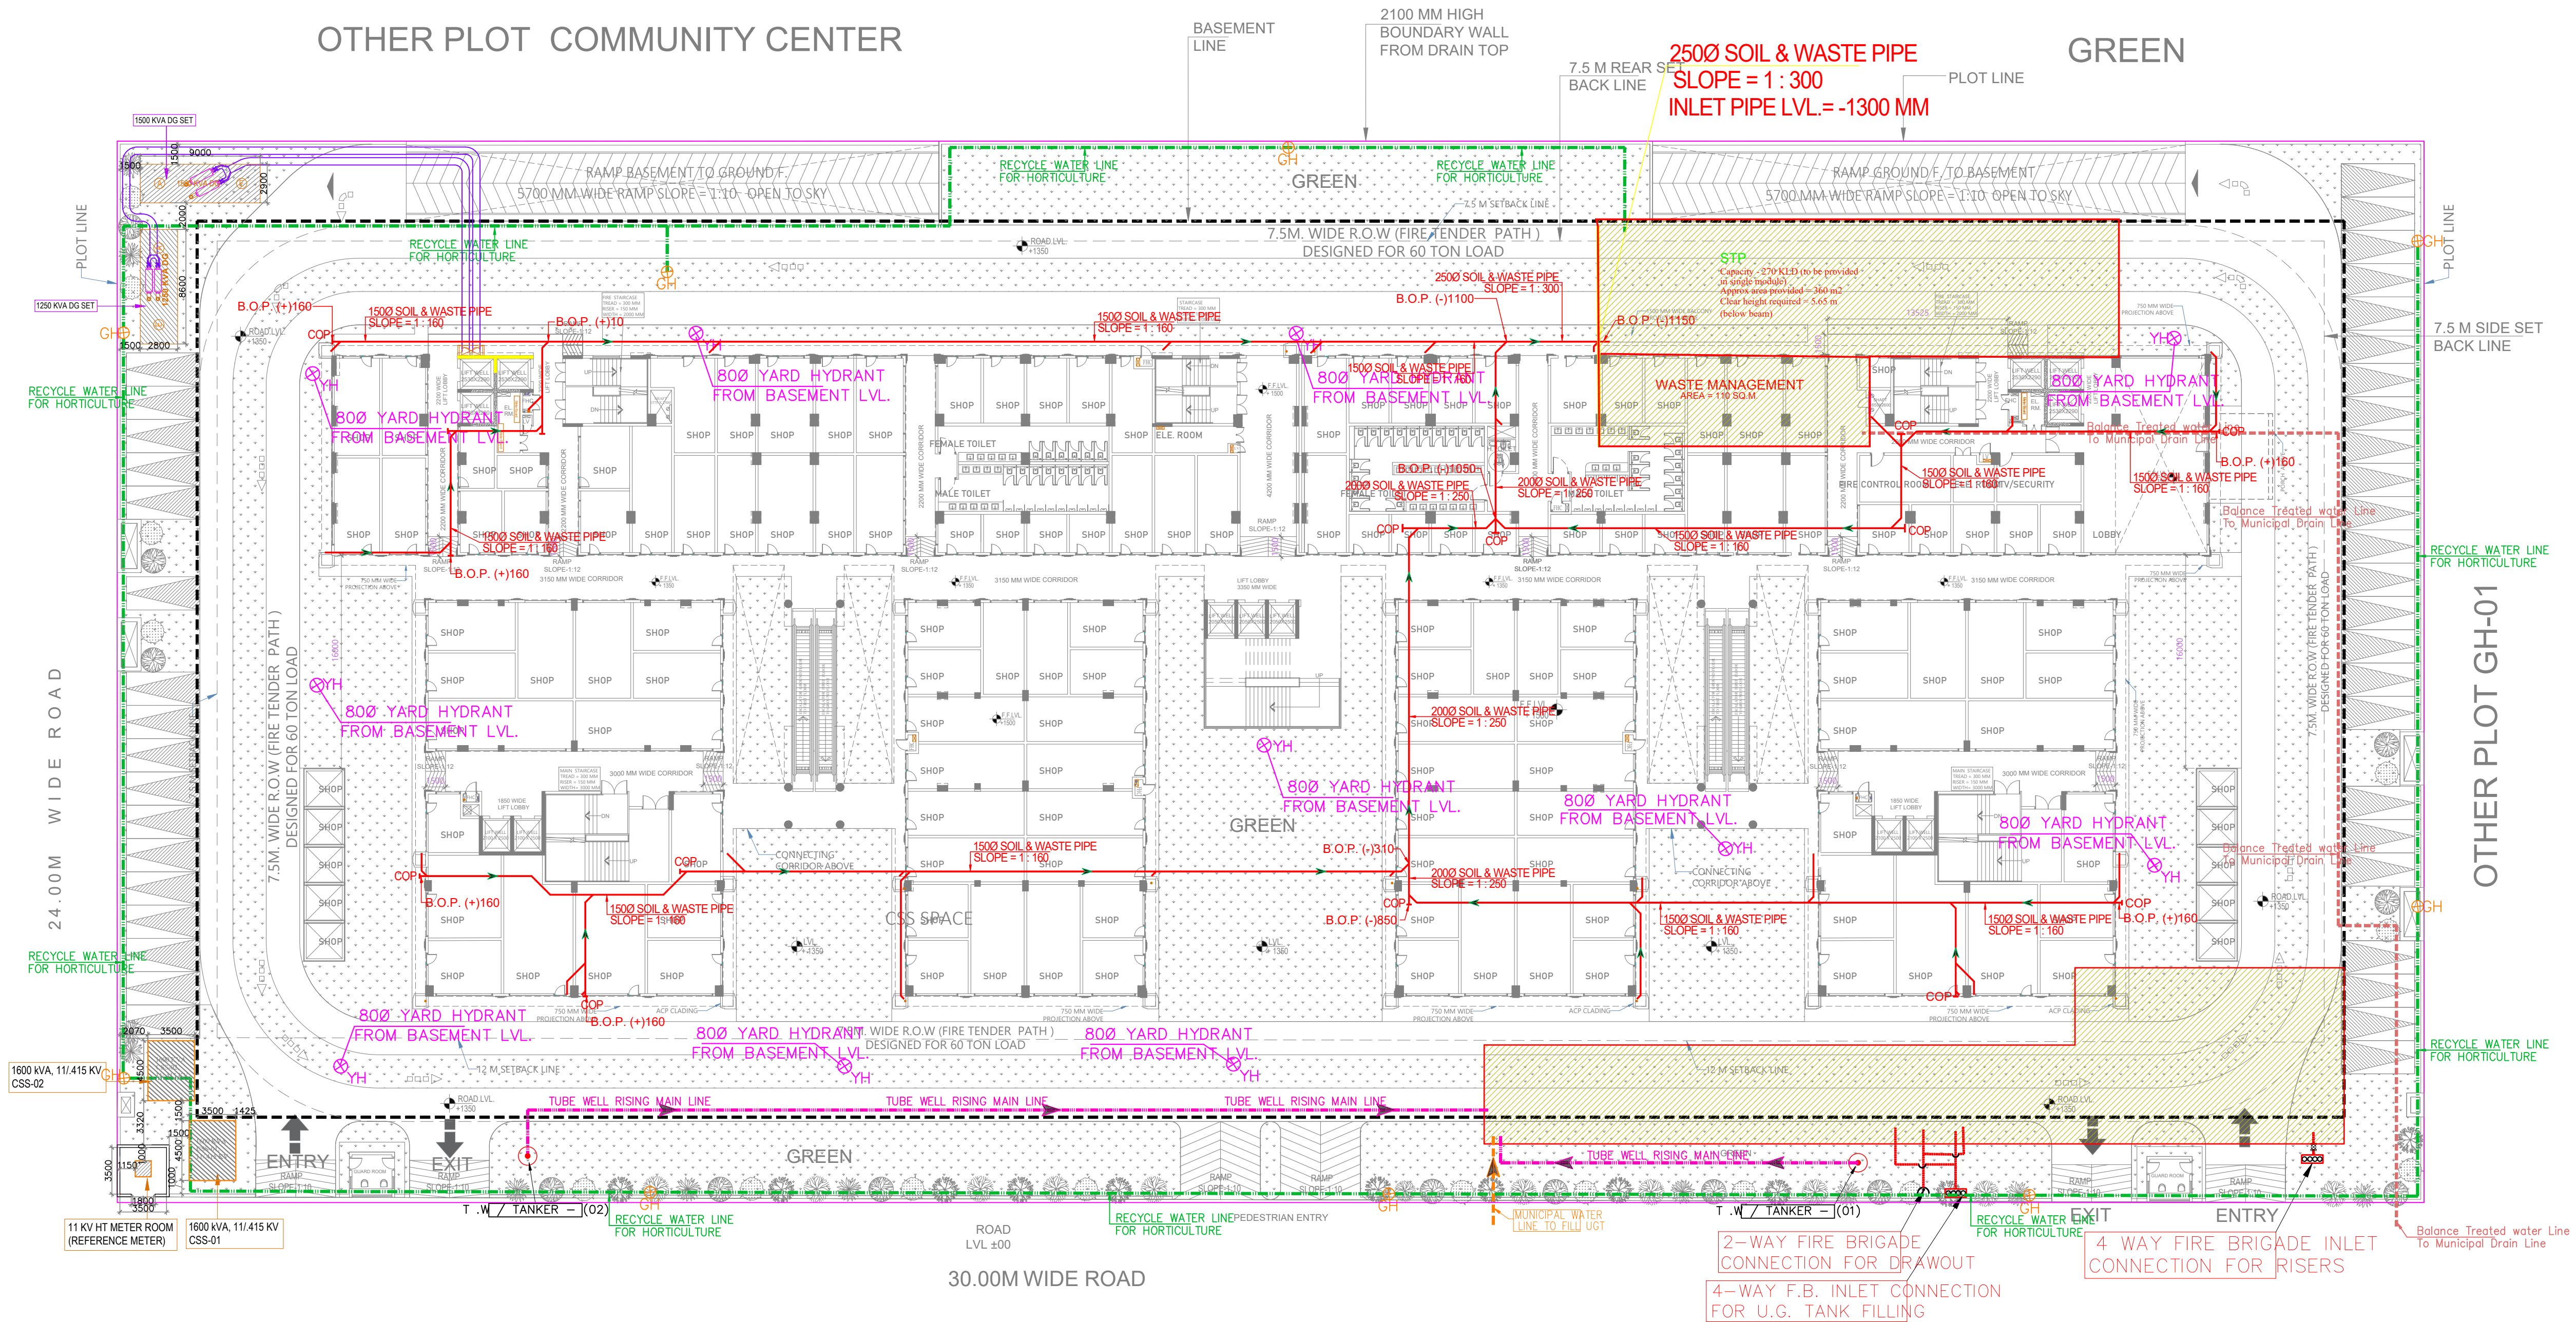

LEGEND :

S. No.	SYMBOL	DESCRIPTION
1.		RECYCLED WATER SUPPLY PIPE LINE.
2.		ISING MAIN WATER PIPE LINE.
3.		MUNICIPAL WATER SUPPLY PIPE LINE.
4.		ISOLATING VALVE
5.		MASONRY CHAMBER FOR ISOLATING VAL
6.		PROPOSED TUBE WELL
7.		BASEMENT LINE
8.		GARDEN HYDRANT

LEGEND : FIRE SYSTEM

S. No.	SYMBOL	DESCRIPTION
1.		FIRE LINE
2.		YARD HYDRANT 63 M.M. DIA. SINGLE HEADED HYDRANT VALVE WITH 2 NOS. 15 M. LONG, 63 M.M. DIA. FIRE HOSE PIPE & 1 NO. BRANCH PIPE WITH NOZZLE
3.		FIRE BRIGADE CONNECTION
4.		BUTTERFLY VALVE
5.		NONRETURN VALVE (CHECK VALVE)
6.		ISOLATING VALVE WITH MASONARY CHAMBER

Rev. No. Date Revision

OWNER

M/S LOGIX BULDESTATE PVT. LTD.

project PROPOSED COMMERCIAL CENTER
C-1 AT PLOT NO ,
TS-1B, SECTOR-22D, YAMUNA
EXPRESSWAY, (U.P.) BELONGING
TO M/S LOGIX BULDESTATE PVT.
LTD.

title
SITE PLANsubtitle
EXTERNAL WATER SUPPLY SERVICES

drawing released for
☐ APPROVAL ☒ SUBMISSION
☐ ADVANCE COPY ☐ CONSTRUCTION

drg. no. COMMERCIAL/EX / S-03 drawn by Kulwant

scale 1 : 300 designed by R.K.

date Mar. 2025 checked by Anand Havelia

architects
Confluence
NEW DELHI, INDIA
F-1, FIRST FLOOR, MIRA CORPORATE SUITES,
ISHWAR NAGAR, NEW DELHI 110065
Ph- +91-11-26926676 confluence.com member of IBCI
Ph- +91-11-40564766 confluence.cdso - 9001 : 2000
architecture urban design hospitality interiors

services consultant
cespl Cespl Consultants Pvt. Ltd.
Noida Office : B - 67, Sector - 67, Noida - 201 301
Tel : (0120) 3225400 / 3225401
e mail : mail@cespl.in, website : www.cespl.in